



FIRST FLOOR PLAN
SCALE: 1/8" = 1'-0"

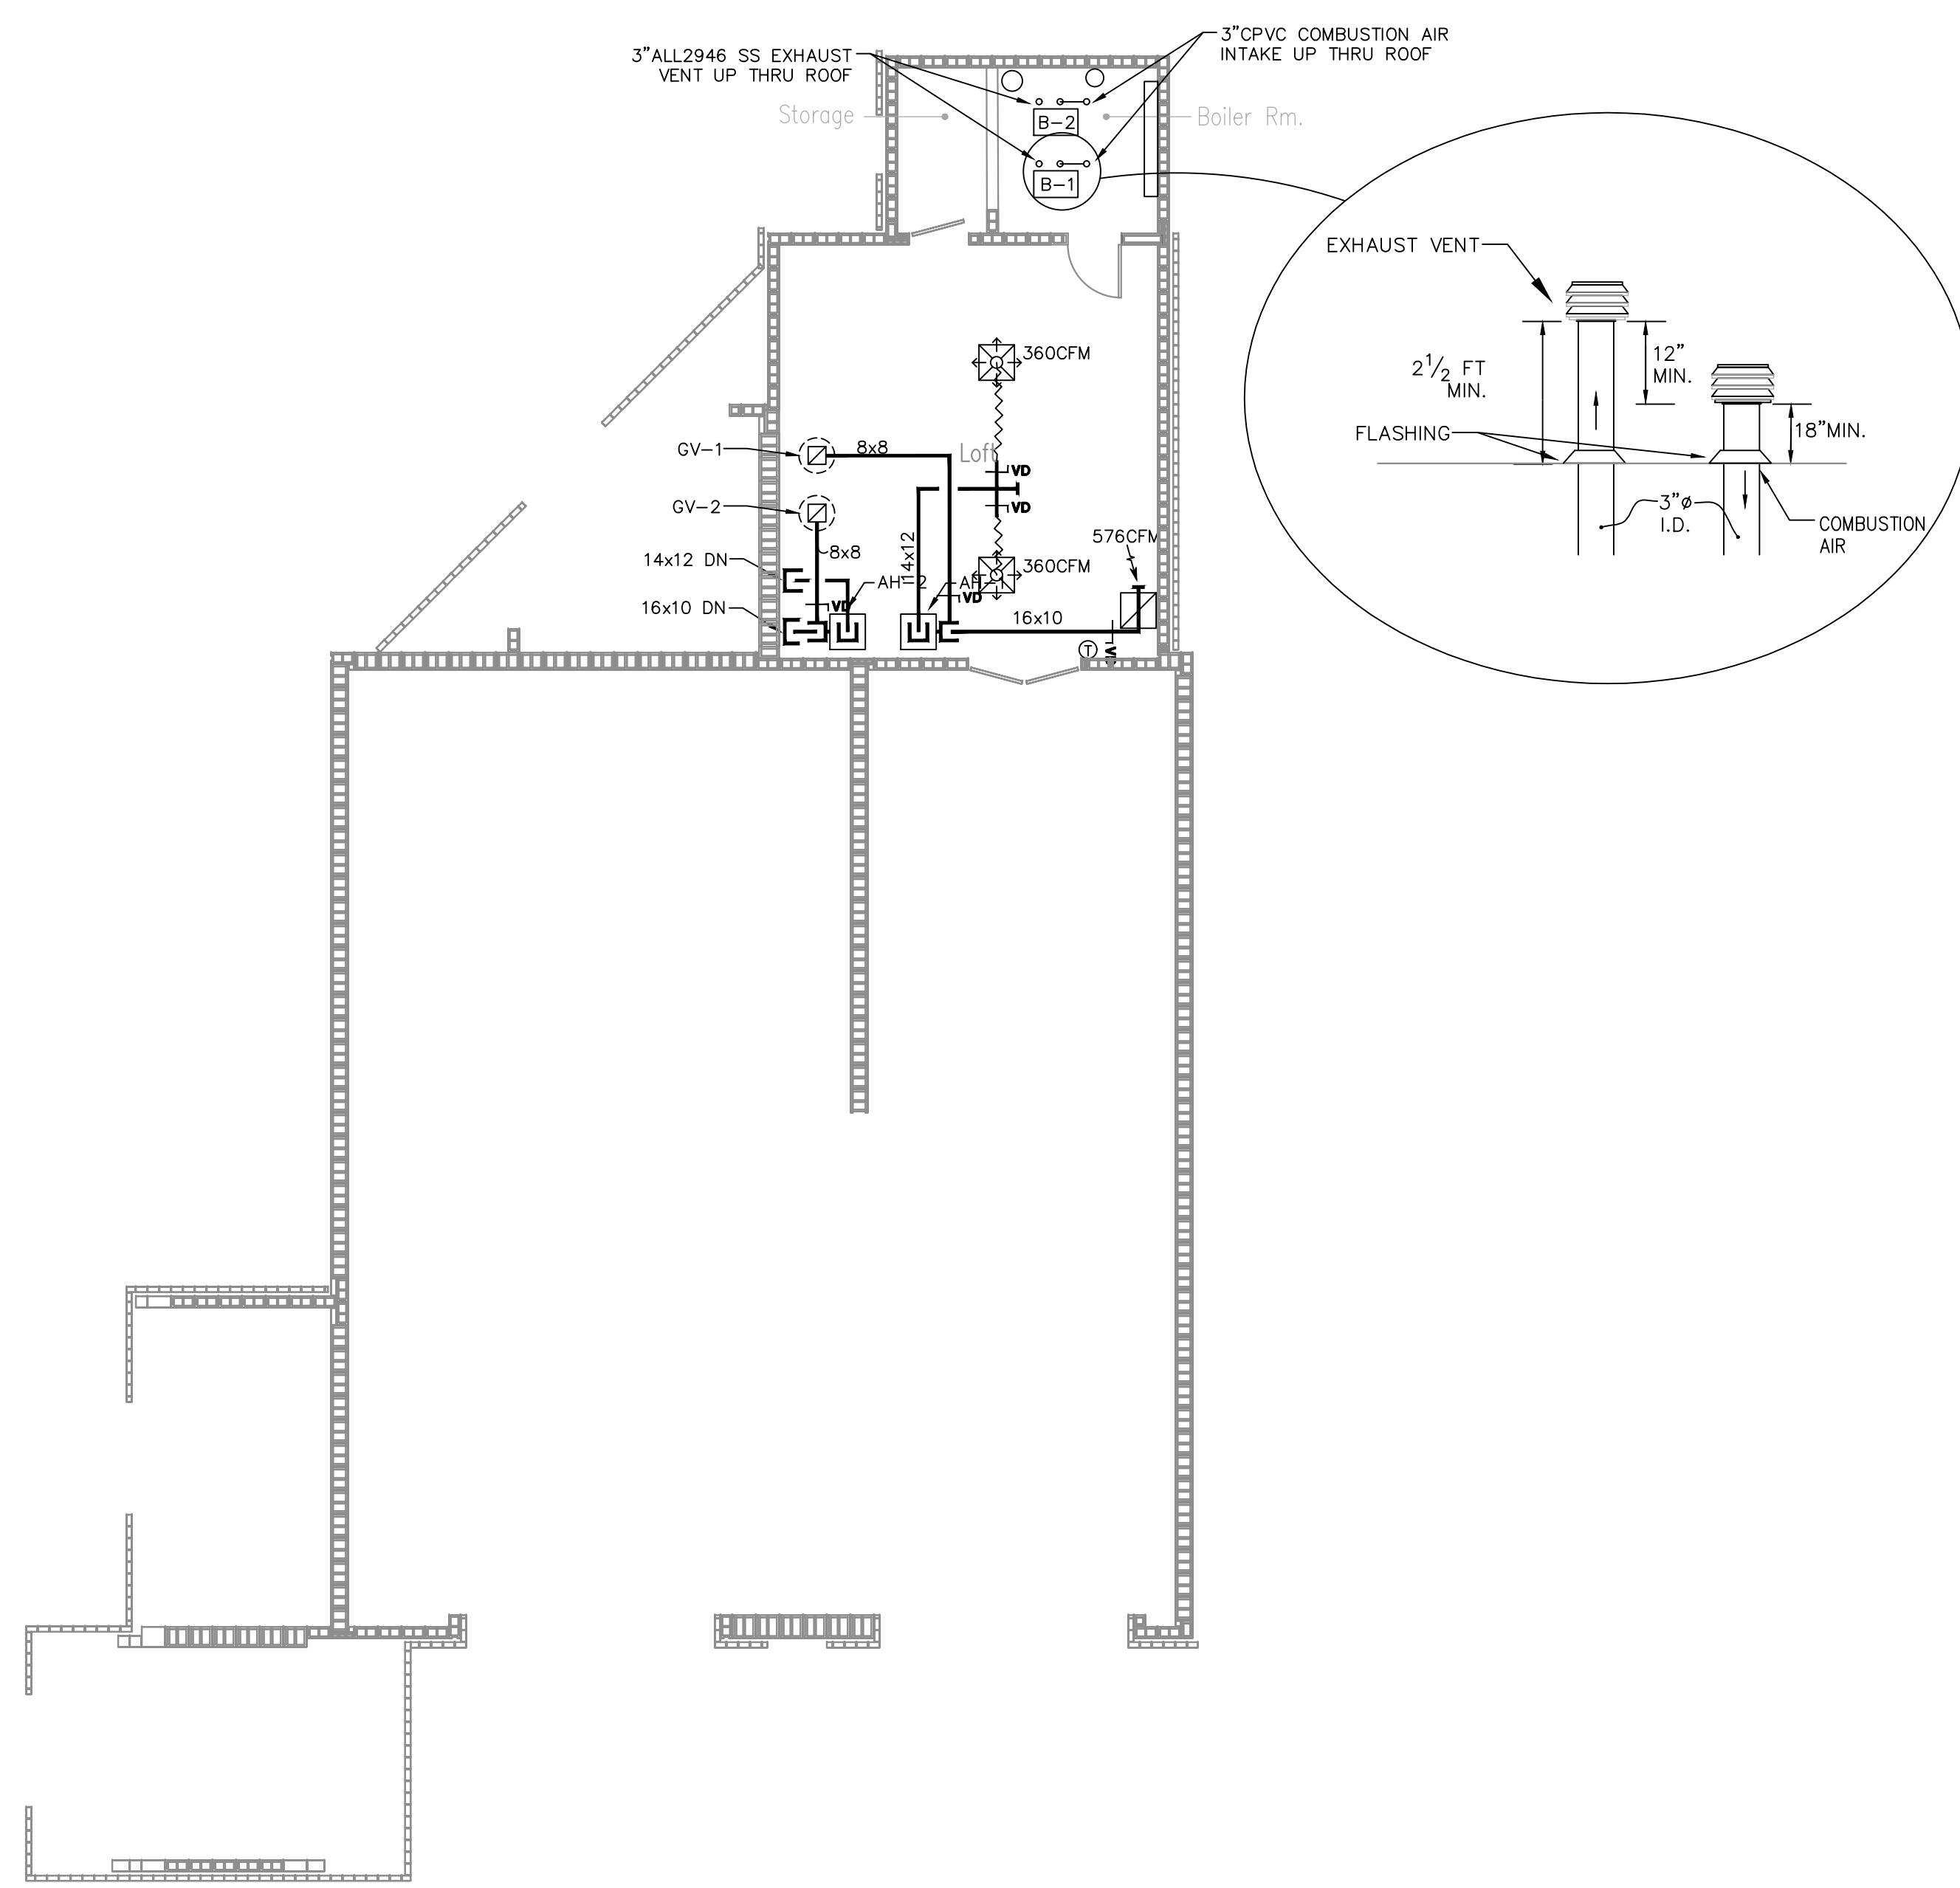

LOFT FLOOR PLAN
SCALE: 1/8" = 1'-0"

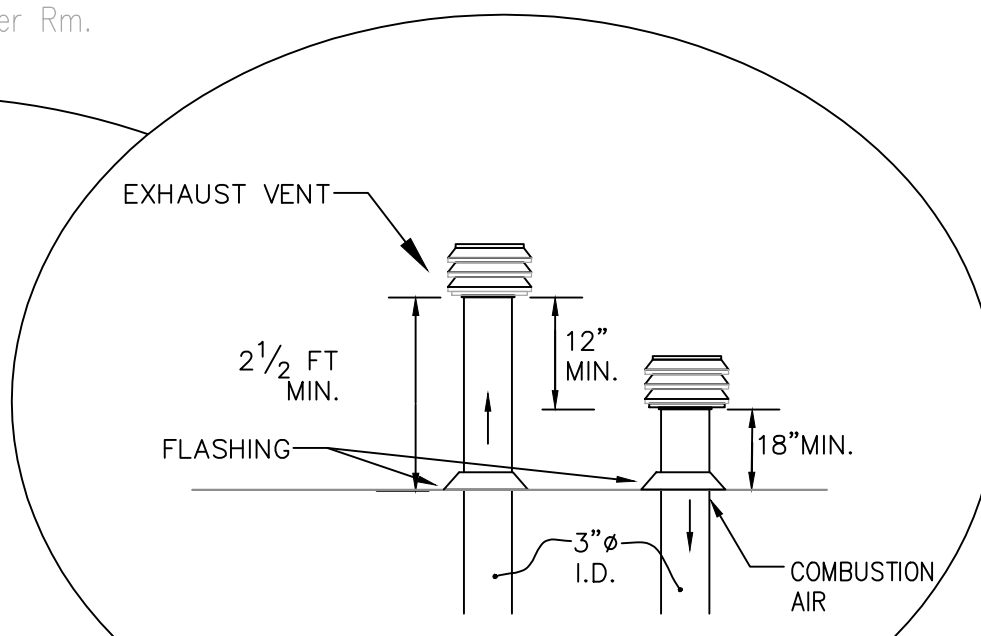

PROJECT SOCIETY HILL AT PISCATAWAY		TITLE MECHANICAL PLANS	
DRAWN BY: GB7/LN	REVISIONS: AS NOTED	ENGINEERS SEAL	
SCALE: 2017.11.9	THIS DRAWING IS INCOMPLETE UNLESS USED WITH ALL OTHER CONTRACT DOCUMENTS	Omdex Incorporated Consulting Engineers	
DATE: 2017.11.9	DRAWING #: M-1	21 Cross Avenue Highland Park, NJ 07432-1811 (201) 444-0753 FAX (201) 444-0839	
Brian W. Pasiecznik, PE NJ #48111 NY #93365 PA #P0706527		Milton A. Azous, PE NJ #21057 NY #48388 PA #P0621488 CT #10684 FL #44942	
Edward J. Cialto PE NJ #26166 NY #57012 Va #01607 DE #11776 MA #1827 Conn #1798 PA #P07688 OH #P51620 Minn #0187409 Mass #33515-IV #33809-R #33634-N NC #18876 SC #20205 NH #6242			