




FIRST FLOOR PLAN
SCALE: 1/8" = 1'-0"

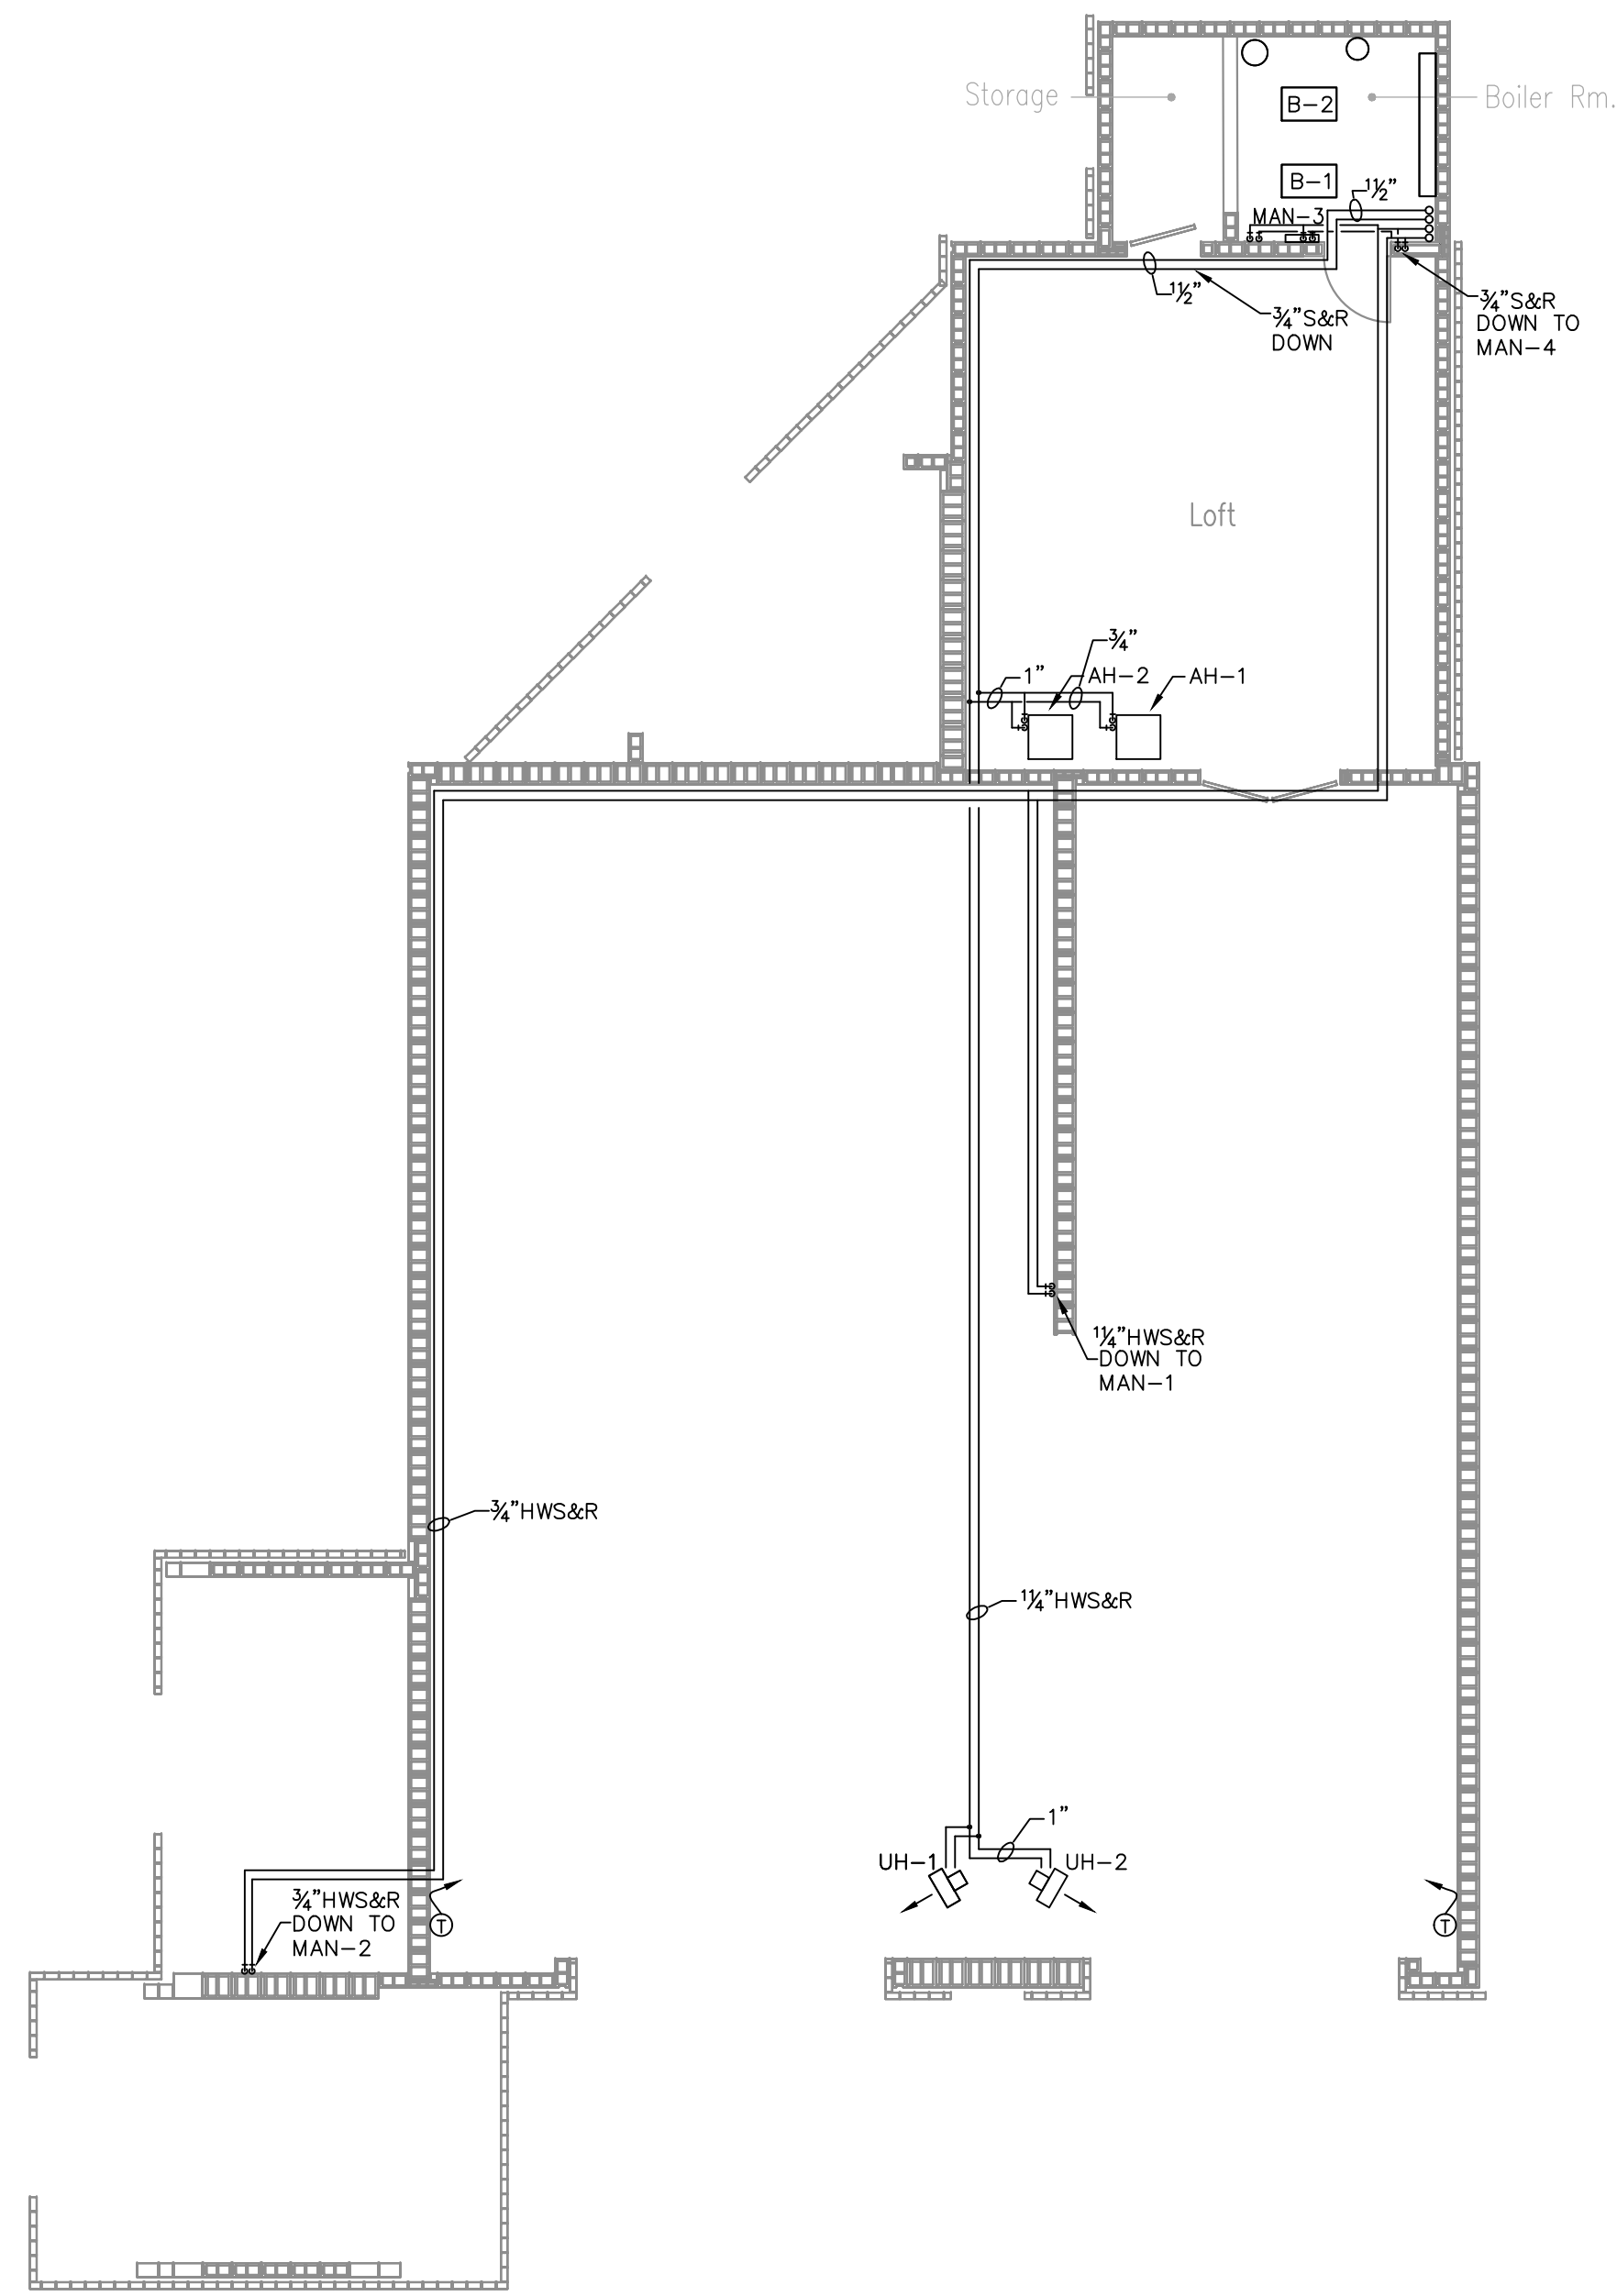

LOFT FLOOR PLAN
SCALE: 1/8" = 1'-0"

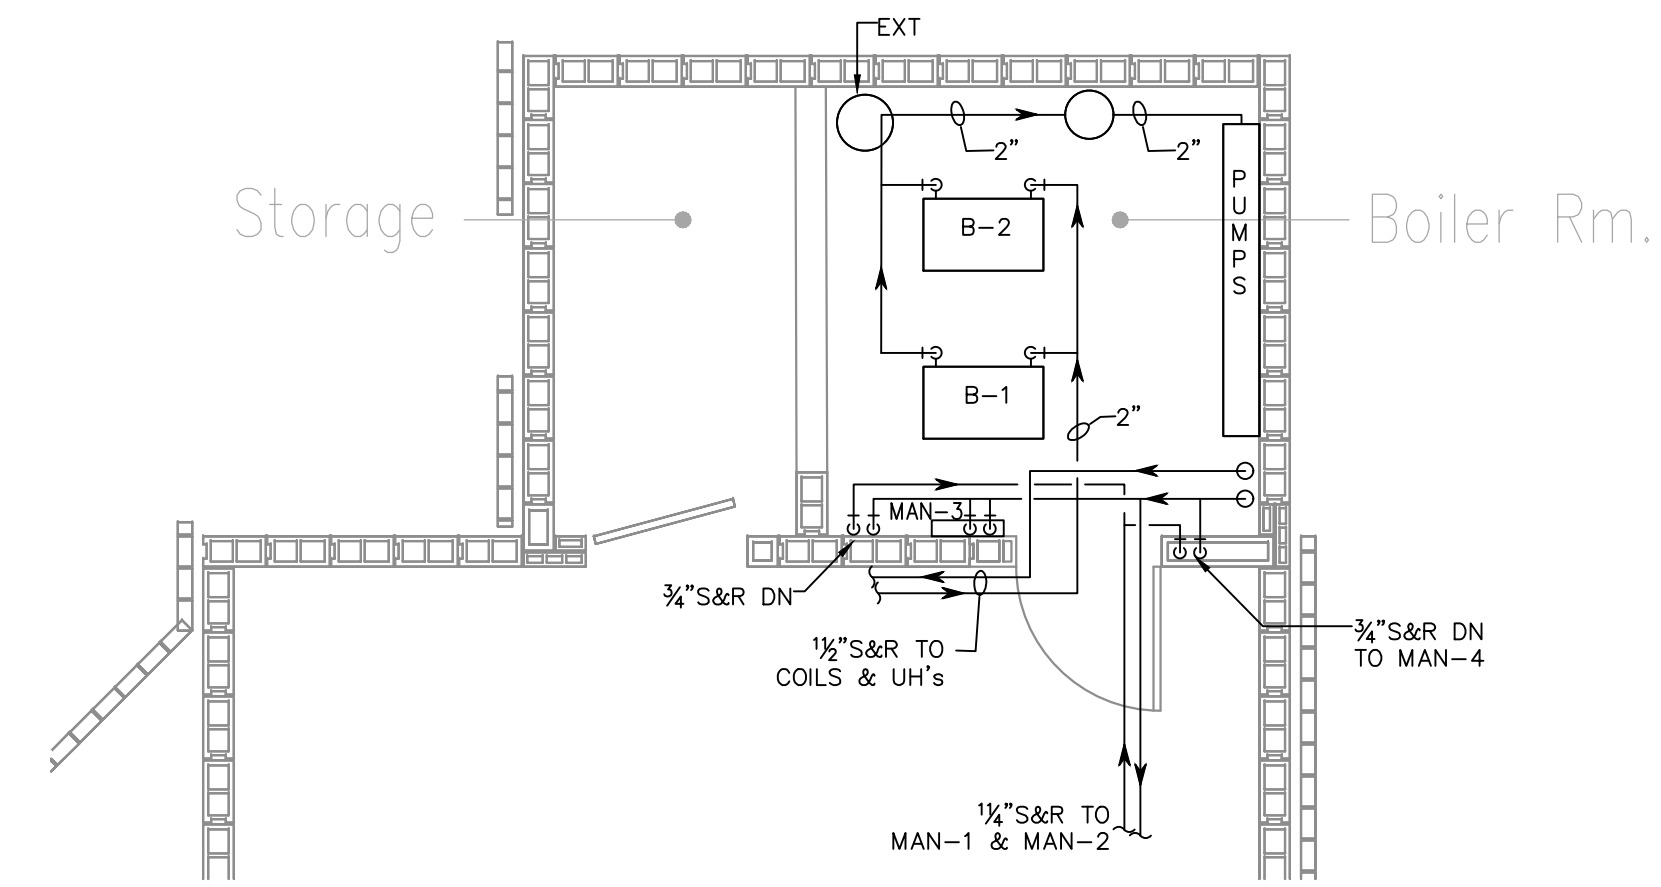

BOILER ROOM PART PLAN
SCALE: 1/4" = 1'-0"

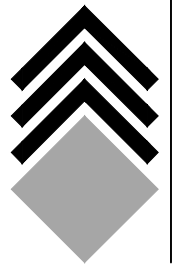ENGINEERS SEAL Omdex Incorporated Consulting Engineers  21 Cross Avenue Zelienople, PA 15085 (201) 444-0755 FAX (201) 444-0839		
Brian W. Paschnick, PE NJ #4811 NY #9385 PA #P070527	Milton A. Azous, PE NJ #21057 NY #48388 PA #P021488 CT #10684 TN #4942	Edward J. Gallo PE NJ #26166 NY #57012 Va #016807 De #11776 MA #1827 Conn #14788 PA #P07888 OH #P61620 MD #0187609 Mass #33515-1W #33899-F #33834-N NC #10873 SC #20205 NH #8242
PROJECT: SOCIETY HILL AT PISCATAWAY TITLE: MECHANICAL PIPING PLANS		
DRAWN BY: SCALE: DATE: DRAWING #:	REVISIONS: GB/LN AS NOTED 2017.11.9 THIS DRAWING IS INCOMPLETE UNLESS USED WITH ALL OTHER CONTRACT DOCUMENTS	M-2